


SECTION 2/13 3\"/>

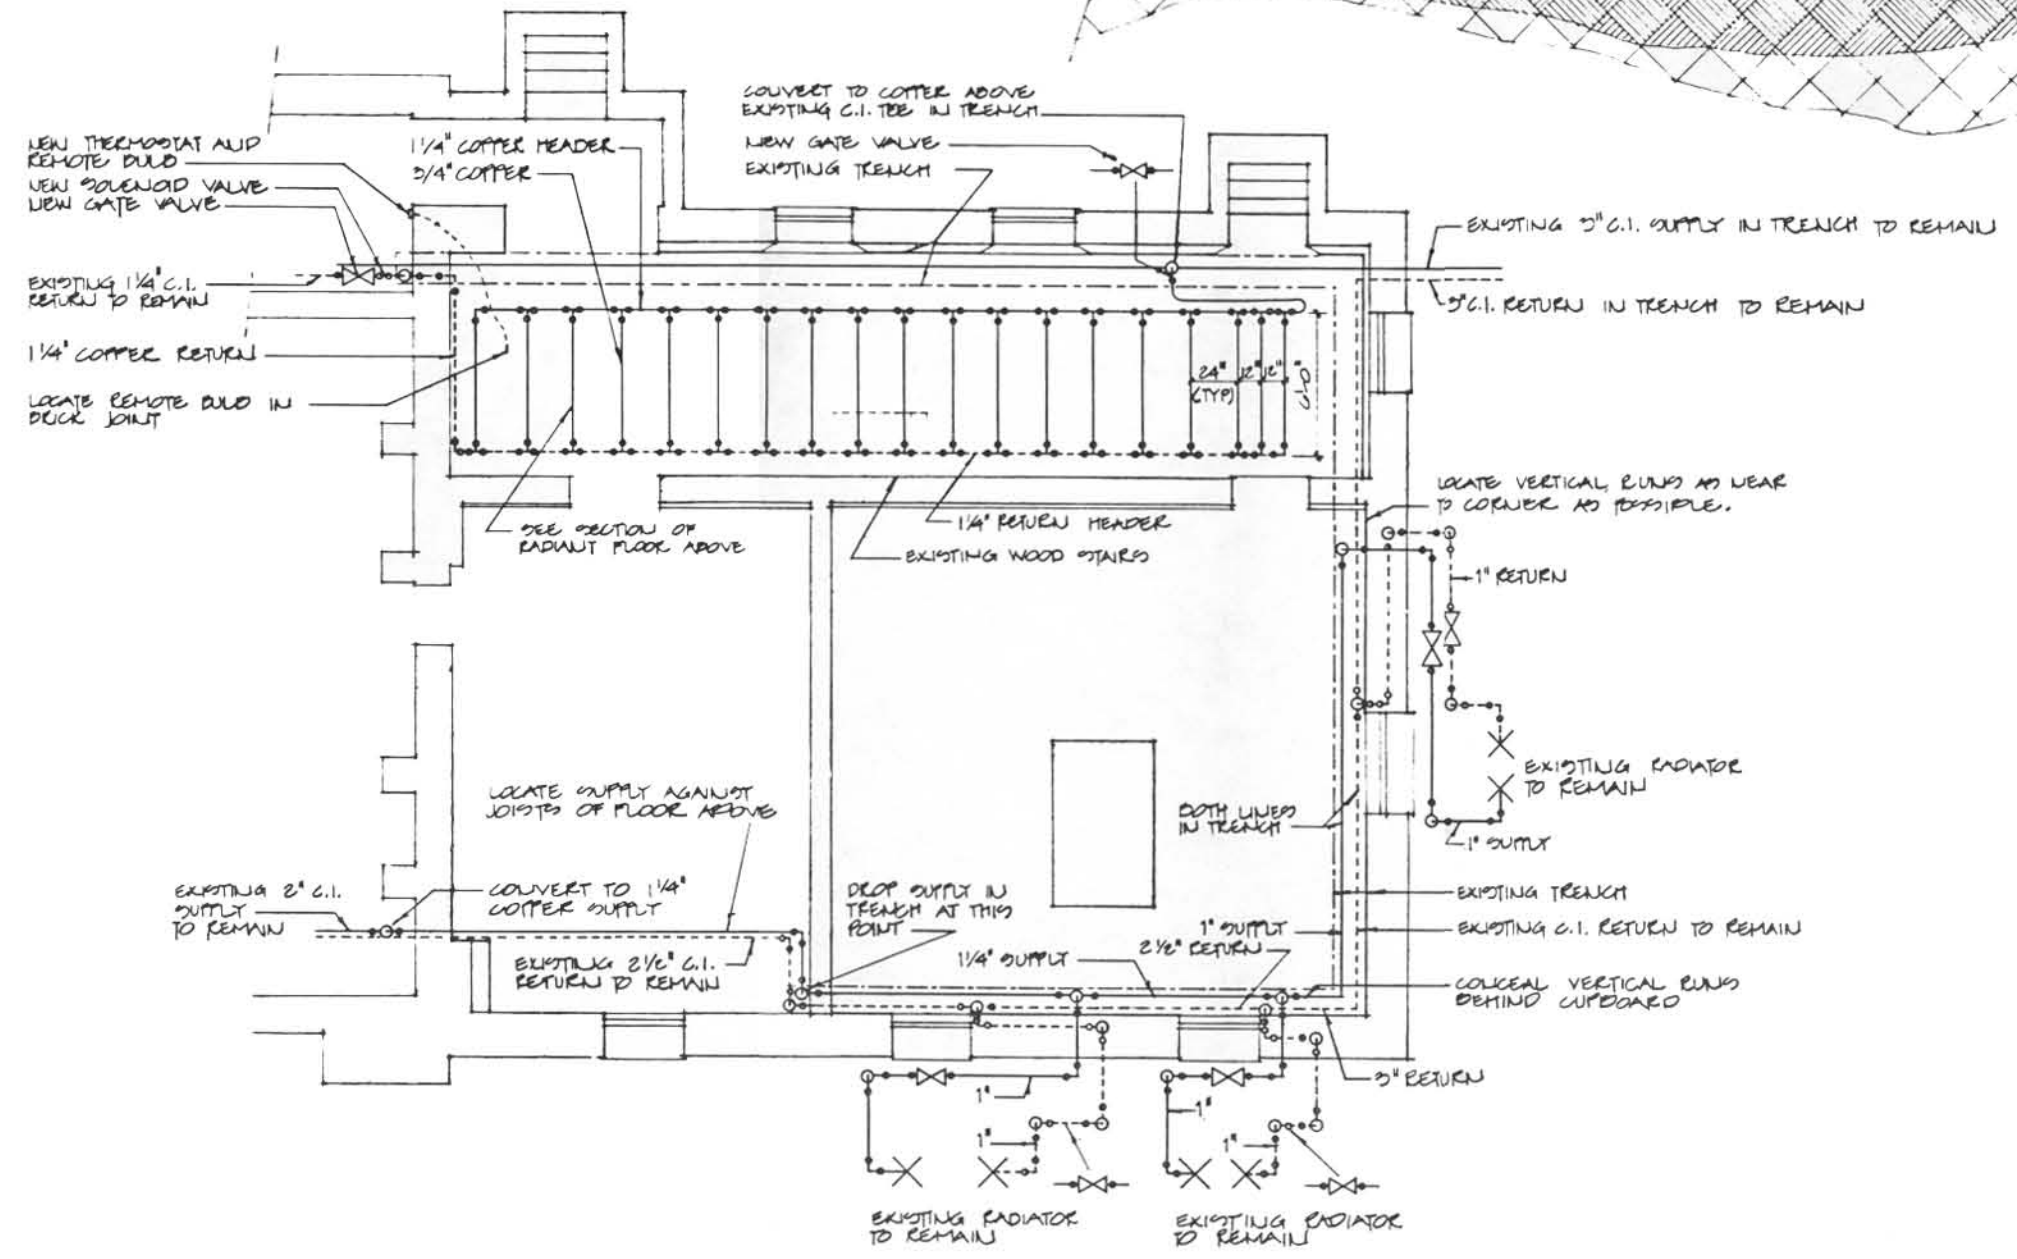

ALL WORK PERFORMED IN 1980

NOTE: PLUMBING FOR RADIATORS IS NOT SHOWN TO SCALE. RADIATORS ARE LOCATED IN RECEPS BELOW WINDOWS ABOVE.

PLAN N. WING HEATING LAYOUT 1/13 1/4\"/>

PREPARED	DESIGNED	DRAWN	CHECKED	DATE	DRAWING NO.	SHEET
					850	13
					25,000	OF 13
					PCIP PKG	
					500	
					1/13/80	