



LEGEND

 
1. CUSTOMS
2. CHECKING & INFORMATION
3. OFFICES
4. TICKETS
5. LOBBY
6. COFFEE SHOP
7. KITCHEN
8. TAVERN
9. TRANSPORTATION
10. LOUNGE
11. CURIO
12. GUEST ROOMS - 20 ON 2ND FLOOR
13. APARTMENTS - 2 OVER STORE
14. GENERAL STORE
15. POST OFFICE
16. REPAIR SHOP
17. POWER & HEATING PLANT
18. STORAGE IN BASEMENT
19. OFFICES 2ND FLOOR
20. CHECKING STATION

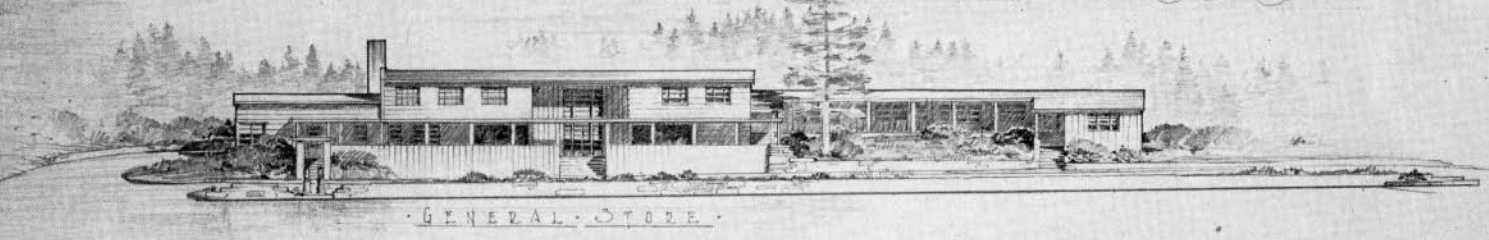


GENERAL STORE

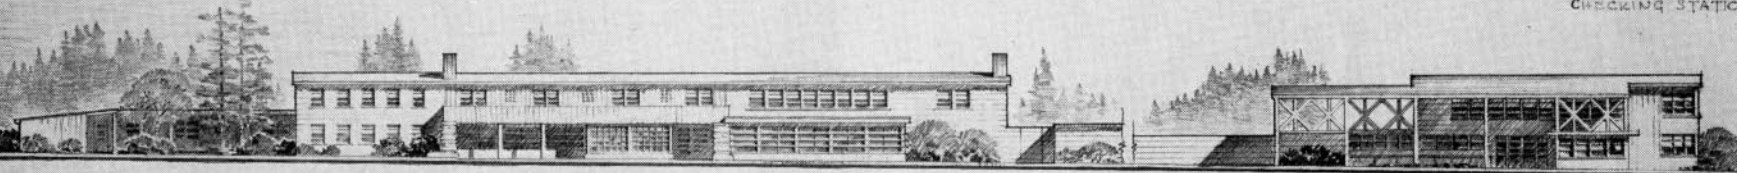

LODGE



CHECKING STATION
CUSTOMS & IMMIGRATION

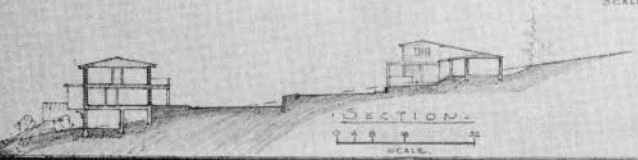

SECTION

U.S. DEPARTMENT OF THE INTERIOR - NATIONAL PARK SERVICE
ALASKA HIGHWAY LAND PLANNING SURVEY

REQUIREMENTS AT THE
YUKON BORDER

SCALE AS SHOWN

APRIL 1944. DESIGNED BY KUEHL & DOTY
DRAWN BY DOTY. DRAWING NO. 10-AH-704A